

EXISTING SERVICE STATION, CARWASH VACUUMS
1801 LANDER AVE, TURLOCK, CA

DEVELOPMENT CONTACTS

BUILDING: AGC DESIGN CONCEPT
CONTACT: ALEX CUEVAS
28524 CONSTELLATION RD.
VALENCIA CA. 91355
PH.#: (661)295-1111

ARCHITECT
CONTACT: DANIEL CLINE
28524 CONSTELLATION RD.
VALENCIA CA., 91355
PH.#: (661) 294-9423


CODE INFORMATION

1. APPLICABLE CODES:

BUILDING CODE: 2016 CALIFORNIA BUILDING CODE
ELECTRICAL CODE: 2016 CALIFORNIA ELECTRICAL CODE
MECHANICAL CODE: 2016 CALIFORNIA MECHANICAL CODE
PLUMBING CODE: 2016 CALIFORNIA PLUMBING CODE
FIRE CODE: 2016 CALIFORNIA FIRE CODE
ENERGY CODE: 2016 CA. ENERGY EFFICIENCY STANDARDS
GREEN CODE: 2016 CA. GREEN BUILDING CODE

SCOPE OF WORK

VACUUM ADDITIONS

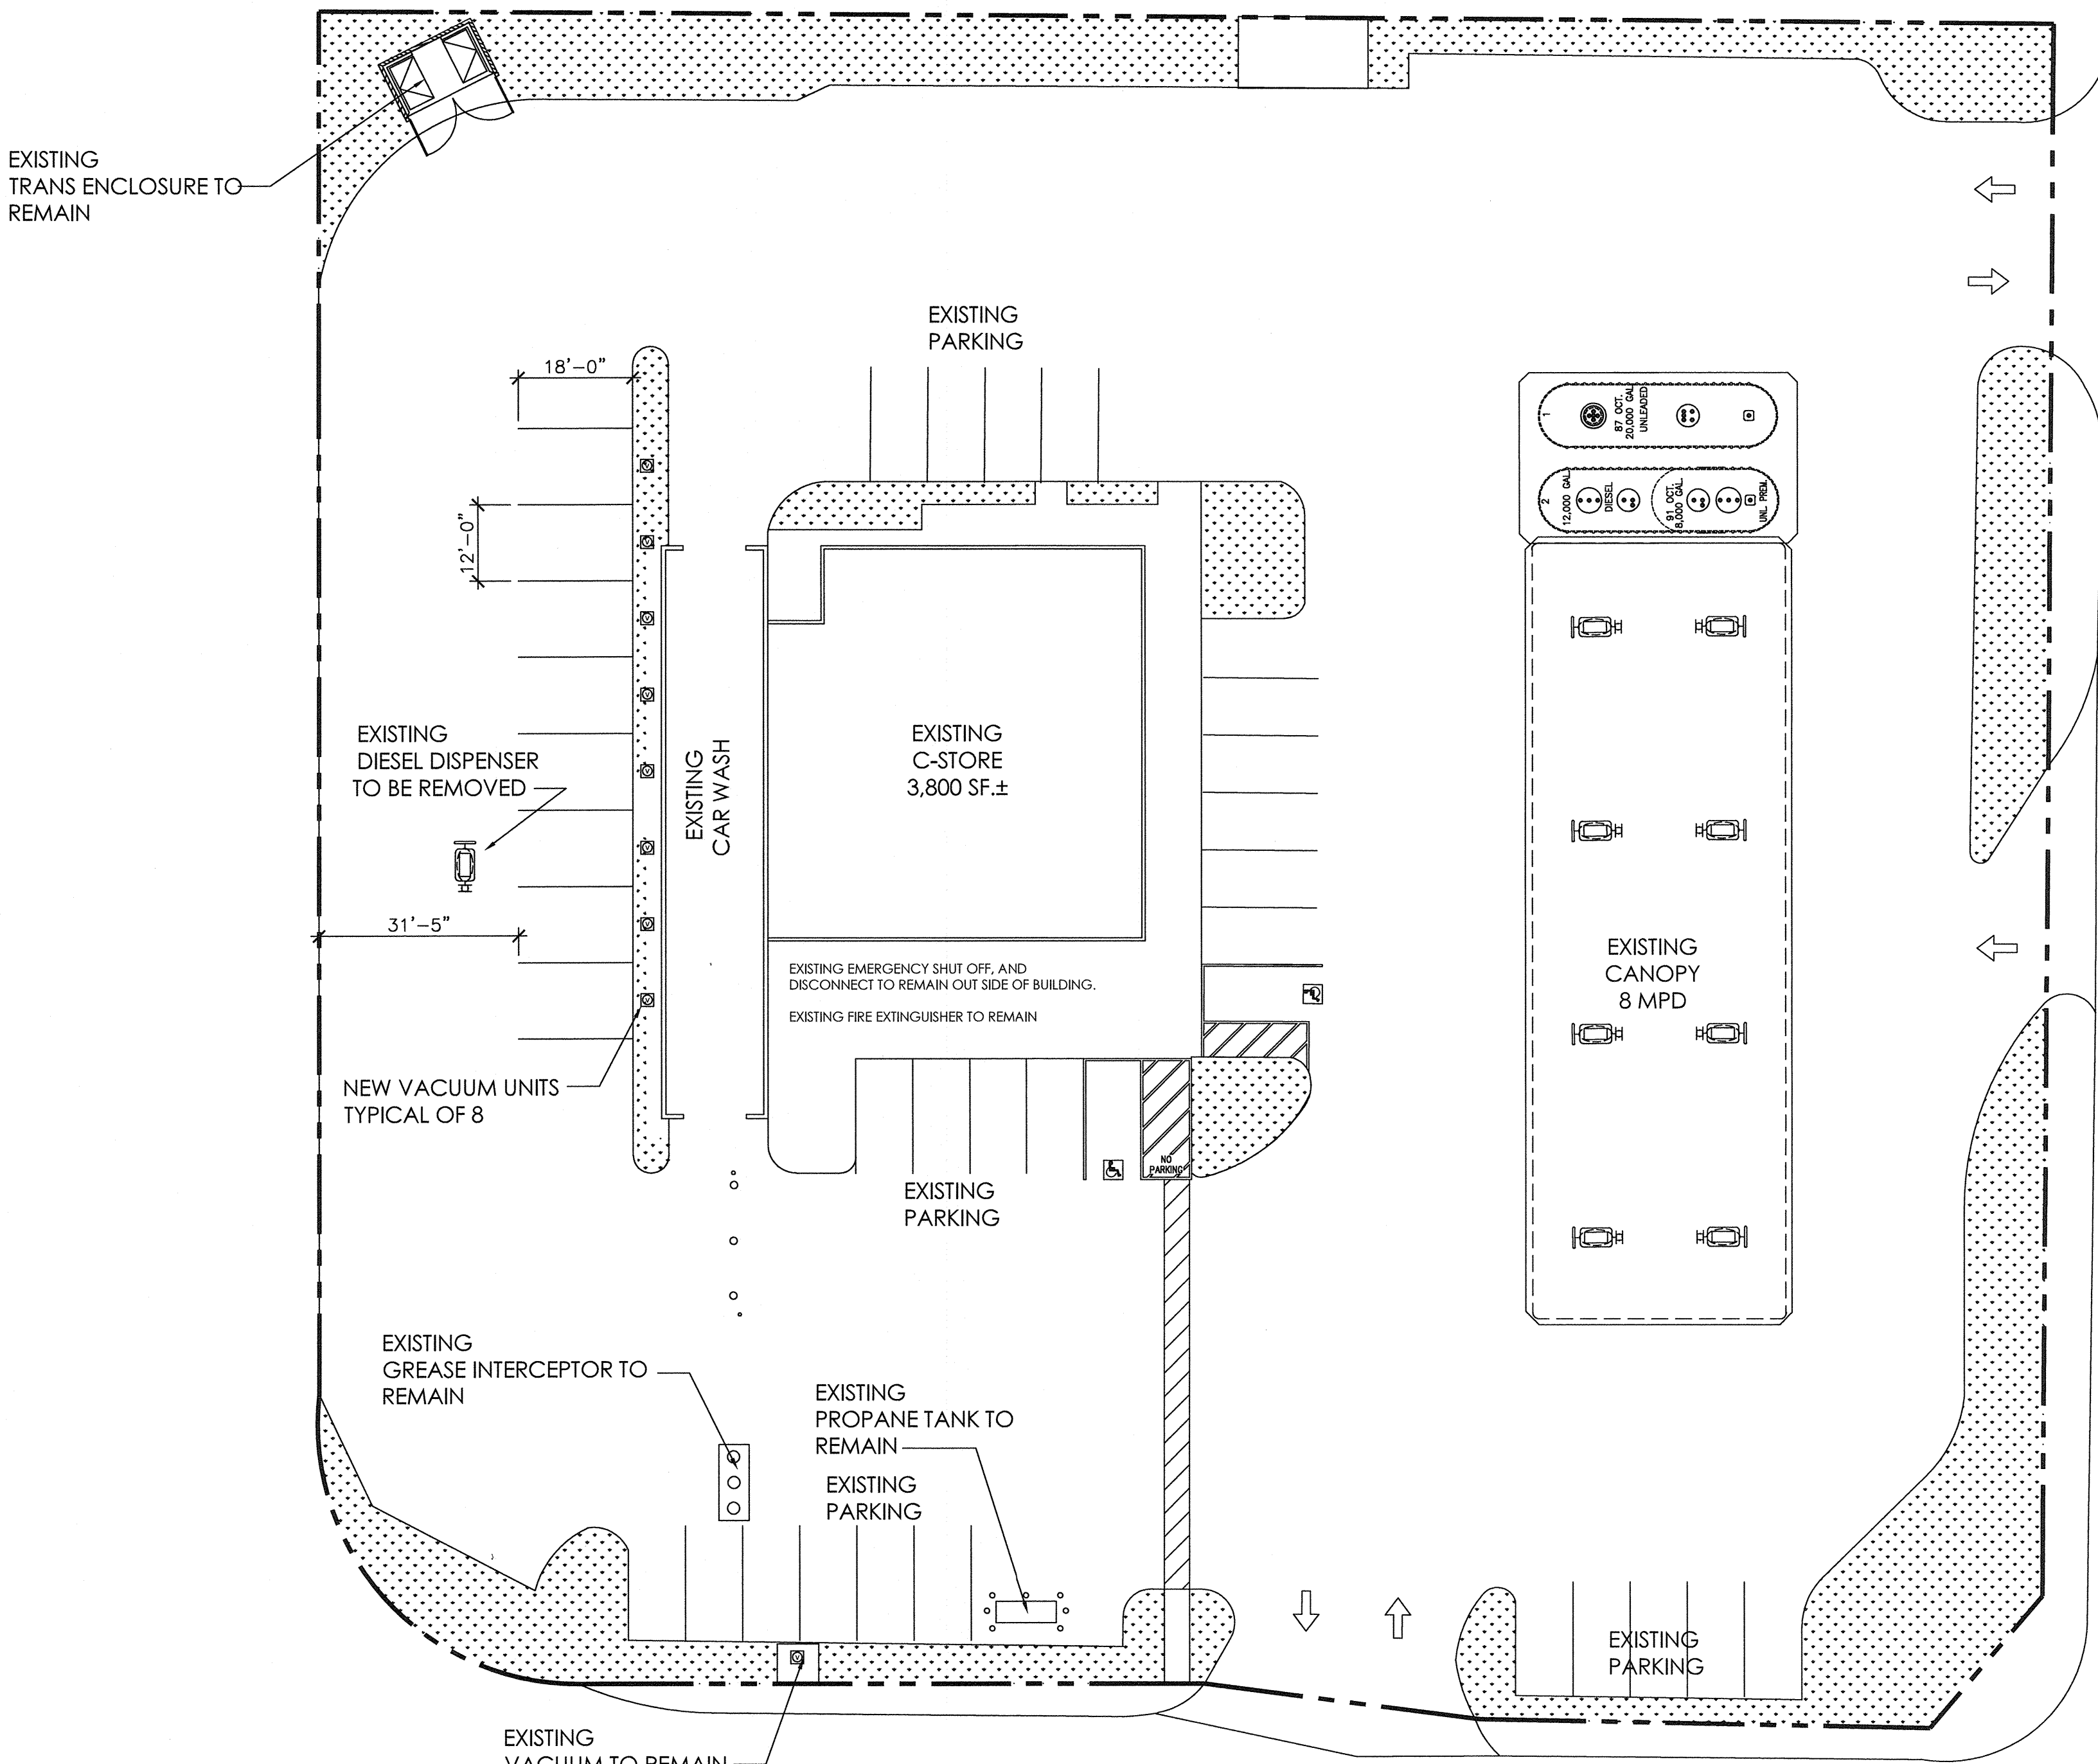


3/1/18

1 EXISTING SITE PLAN
SCALE: 1"=20'




LANDER AVE.

E. GLENWOOD AVE

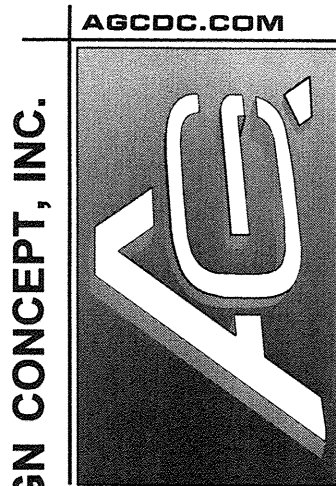

AGC DESIGN CONCEPT, INC.
28524 Constellation Rd
Valencia, CA 91355
Phone: 661.295.1111
Fax: 661.294.9423

NO.	DATE	REVISIONS	BY

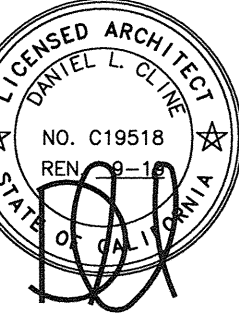

EXISTING GAS STATION
AM/PM C-STORE, CAR WASH, 8 MPD CANOPY
1801 LANDER AVENUE
TURLOCK, CA

consultant job#	
master release date	
project exe date	master drawn by
Filename AGC-431	
Facility/Project	
sheet name	