

OCCUPANT LOAD INFO.		OCCUPANT LOAD INFO.		OCCUPANT LOAD INFO.	
TYPE OF CONSTRUCTION :	A-3	(E) SANCTUARY AREA	ACTUAL AREA :	(E) BAR/LOUNGE AREA	ALLOWABLE BUILDING AREA :
NO. OF STORES :	1	ACTUAL AREA :	5,474 sq. ft.	ACTUAL AREA :	UNLIMITED
FIRE SPRINKLER SYSTEM :	YES	TYPE OF CONSTRUCTION :	A-3	TYPE OF CONSTRUCTION :	A-3
CRC EDITION :	2013	FIRE SPRINKLERS :	YES	OCCUPANCY GROUP :	A-2
BUILDING AREA :	15,642 sq. ft.	TOTAL OCCUPANT LOAD :	189 People	FIRE SPRINKLERS :	YES
AREA OF SUITE :	5,239 sq. ft.	(E) SANCTUARY AREA :	187 People	TOTAL OCCUPANT LOAD :	781 People
TOTAL OCCUPANT LOAD :	370 People	(E) RESTROOM/STORAGE :	2 People	(E) BANQUET & BAR USES :	422 People
OFFICE AREAS :	540 / 100 = 5 Pkgs			(E) GAZEBO AREA :	11 People
CLASSROOMS :	207 / 500 = 2 Pkgs				
FOYER & SANCTUARY :	2100 / 7 = 300 "				
RESTROOM (PLUMBING) FIGURE LOAD :	97 People				
OFFICE AREA :	540 / 200 = 2 Pkgs				
RESTROOMS/STORAGE :	577 / 500 = 2 Pkgs				
FOYER & SANCTUARY :	2100 / 30 = 70 "				
RESTROOMS/STORAGE :	577 / 30 = 19 Pkgs				
FOYER & SANCTUARY :	2100 / 30 = 70 "				
RESTROOMS/STORAGE :	577 / 30 = 19 Pkgs				
FOYER & SANCTUARY :	2100 / 30 = 70 "				
RESTROOMS/STORAGE :	577 / 30 = 19 Pkgs				
FOYER & SANCTUARY :	2100 / 30 = 70 "				

EXISTING SITE/FLOOR PLAN
SCALE: 1" = 10'-0"

S. BROADWAY AVE



YOSHINO-SHAW & ASSOCIATES ARCHITECT
 Jim Shaw
 1216 N. GARDEN STATE BLVD
 TURLOCK, CA 95350
 Phone: (209) 667-2603
 Fax: (209) 667-2604
 Email: jshaw@yoshino-shaw.com


PROJECT NAME: SANCTUARY & FACADE UPGRADES FOR :
CALVARY CHAPEL CHURCH
 147 S. BROADWAY AVE
 TURLOCK, CA

SHEET TITLE: (E)PROJECT DATA & EXISTING FLOOR PLAN
 DATE: 7/27/18
 DRAWN BY: JDS
 JOB NUMBER: 1815

REVISIONS

© 2018 YOSHINO-SHAW & ASSOCIATES

SHEET NO. A-10

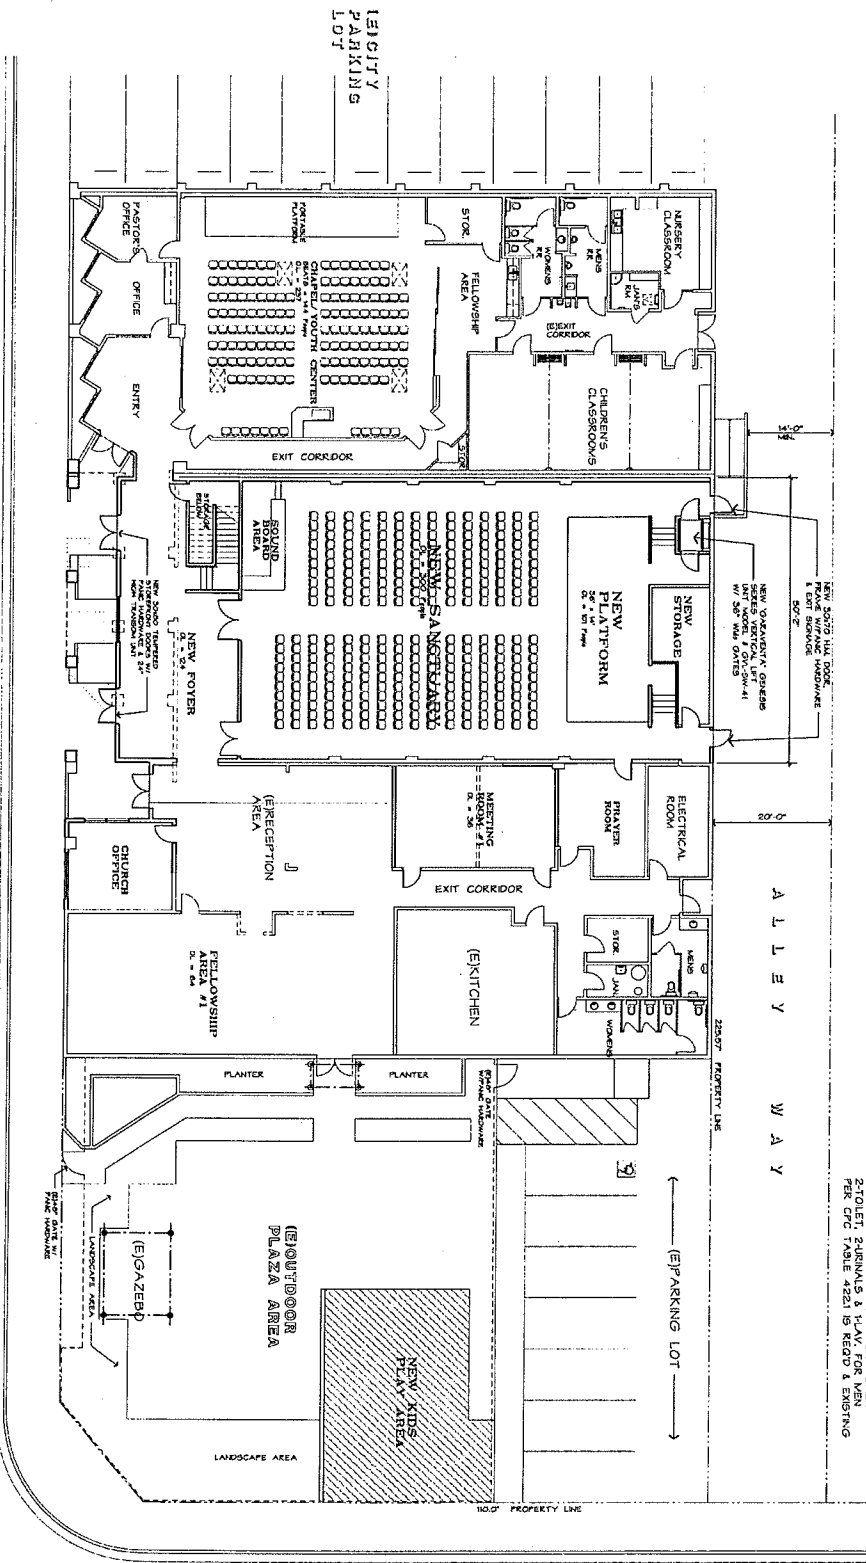

OCCUPANT LOAD INFO.

CHAPEL/YOUTH CENTER AREA :	5,319 sq. ft.	UNDESIGNATED A-S OCCUPANCY AREA
TYPE OF CONSTRUCTION :	V-B	ALLOWABLE BUILDING AREA :
OCCUPANCY GROUP :	A-3	ACTUAL AREA :
FIRE SPRINKLERS :	YES	TYPE OF CONSTRUCTION :
TOTAL OCCUPANT LOAD :	419 People	OCCUPANCY GROUP :
OFFICE AREAS : 435 / 100 = 4 People		FIRE SPRINKLERS :
CLASSROOMS : 205 / 20 = 10 People		TOTAL OCCUPANT LOAD :
FOYER & SANCTUARY : 2429 / 7 = 347 People		
(E) RESTROOM (F) FIRE FIXTURE LOAD : 105 People		

NEW PLUMBING FIXTURE LOAD :	343 People
4 TOILETS & 2 LAVATORIES FOR WOMEN	
4 TOILETS & 2 LAVATORIES FOR MEN	
FIRE FIXTURE LOAD (EXIST) : 19 PEOPLE & EXISTING	

S. BROADWAY AVE

PROPOSED SITE/FLOOR PLAN

SCALE: 1" = 10'-0"



PROJECT NAME: SANCTUARY & FACADE UPGRADES FOR :
CALVARY CHAPEL CHURCH
 147 S. BROADWAY AVE
 TURLOCK, CA


SHEET TITLE: PROPOSED SITE/FLOOR PLAN	DATE: 1/24/19	DRAWN BY: JOS	JOB NUMBER: 1814	SIGNATURE: © 2019 YOSHINO-SHAW & ASSOCIATES
--	------------------	------------------	---------------------	--



REVISIONS

YOSHINO-SHAW & ASSOCIATES
 ARCHITECT
 JIM SHAW
 ONE N. GARDEN STATE BLVD
 TURLOCK, CA 95250

Phone: (209) 667-2425
 Fax: (209) 667-2600
 Email: jshaw@yoshino-shaw.com
 SHEET NO. **A-1.1**

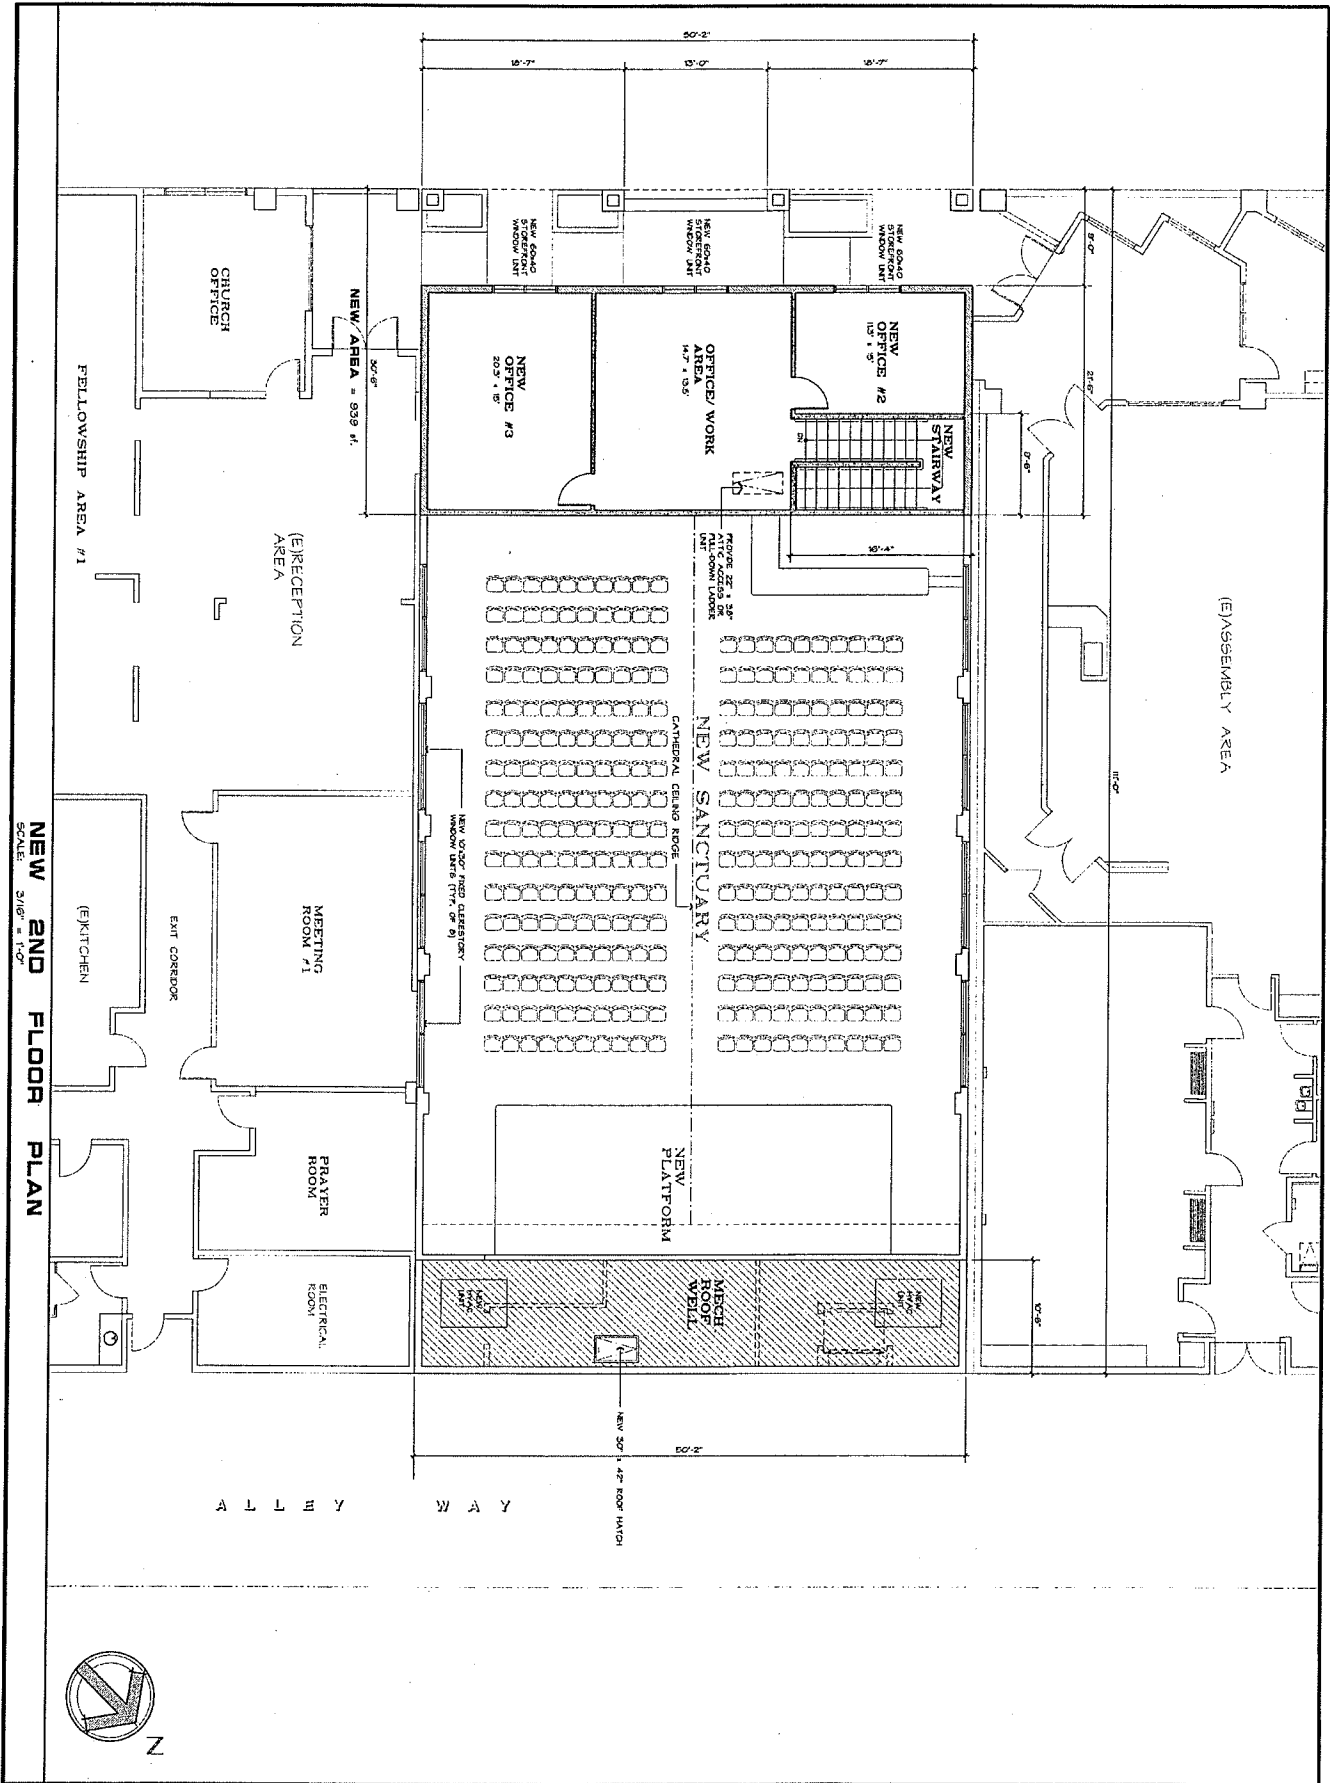

NEW 2ND FLOOR PLAN

SCALE: 3/8" = 1'-0"



A-2.1

YOSHINO-SHAW & ASSOCIATES ARCHITECT
 — Jim Shaw —
 106 N. GARDEN STATE BLVD
 TURLOCK, CA 95290
 Phone: (209) 667-5603
 Fax: (209) 667-5604
 Email: jshaw@ysshaw.com



PROJECT NAME: SANCTUARY & FACADE UPGRADES FOR :

CALVARY CHAPEL CHURCH
 147 S. BROADWAY AVE
 TURLOCK, CA

SHEET TITLE: NEW 2ND FLOOR PLAN

DATE: 1/24/19

DRAWN BY: JDS


JOB NUMBER: 1814

SIGNATURE: _____


© 2019 YOSHINO-SHAW & ASSOCIATES




NO.	REVISIONS

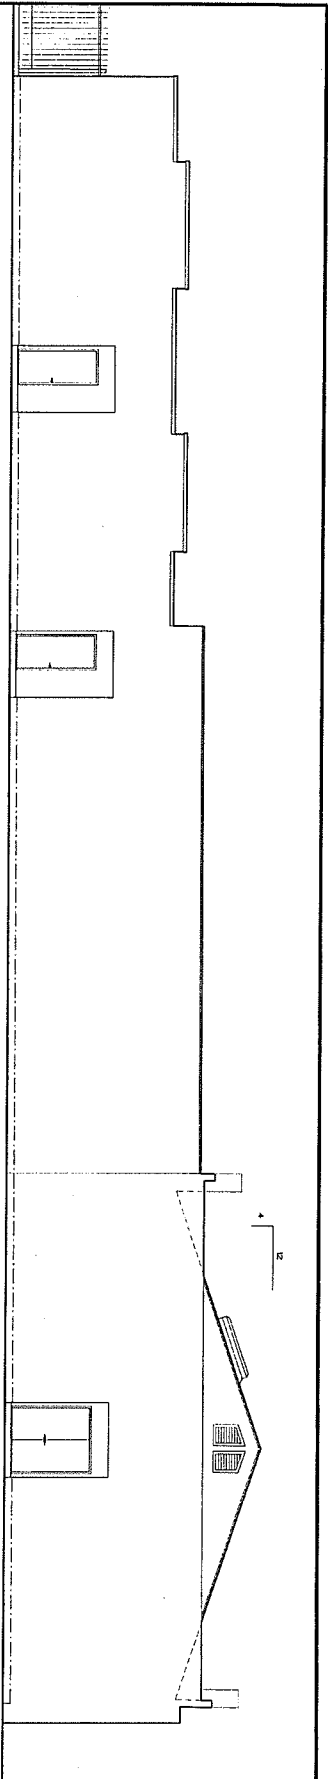

EAST (Rear) ELEVATION

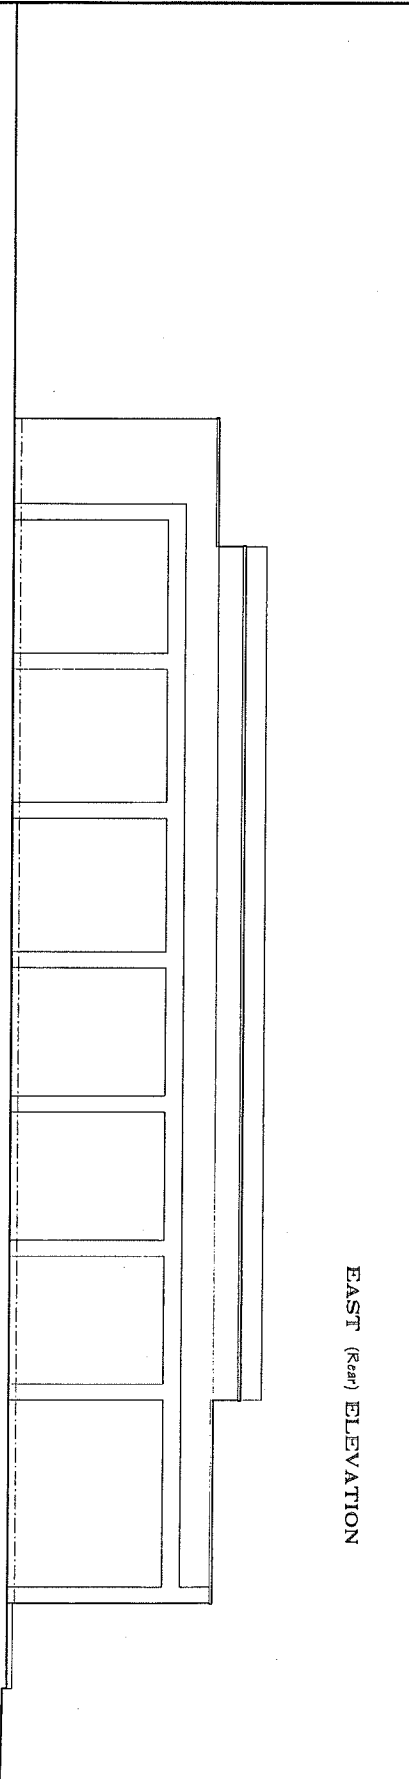

NORTH (Side) ELEVATION

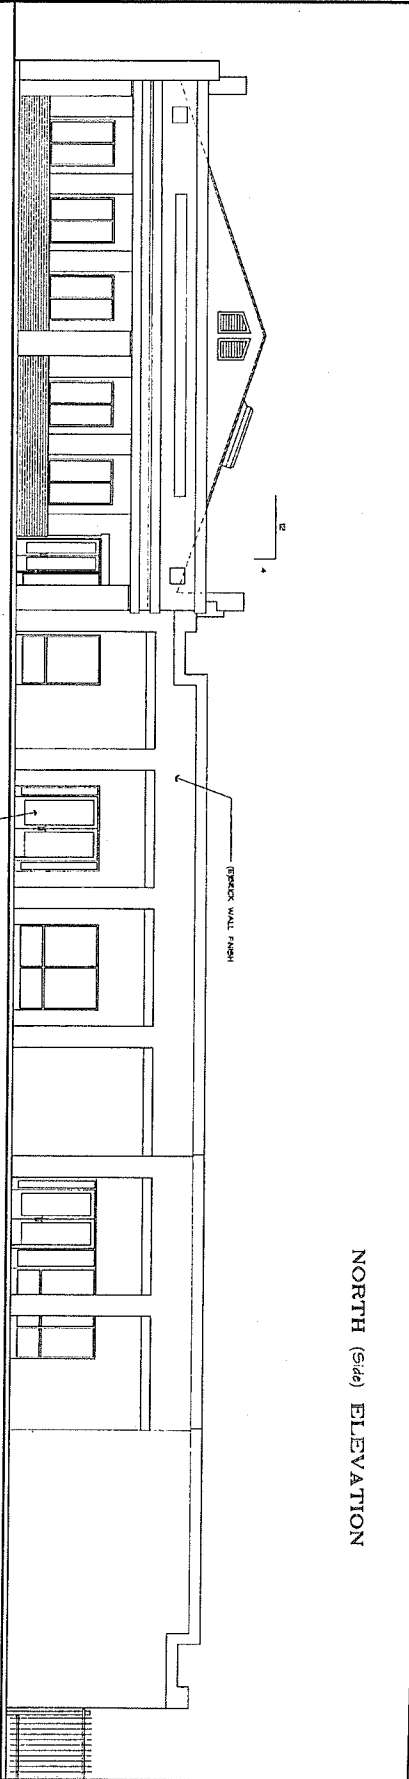

WEST (Front) ELEVATION

TOURNAMENT OPERATIONS
RECOMMENDATION

SPRINKLER WALL FINISH

EXISTING EXTERIOR ELEVATIONS

SCALE: 3/16" = 1'-0"

A

REVISIONS



PROJECT NAME: SANCTUARY & FACADE UPGRADES FOR :

CALVARY CHAPEL CHURCH
147 S. BROADWAY AVE
TURLOCK, CA

SHEET TITLE: EXISTING EXTERIOR ELEVATIONS	DATE 7/27/15	DRAWN BY: JDS	JOB NUMBER: 1815	SIGNATURE
--	-----------------	------------------	---------------------	-----------


© 2015 YOSHINO-SHAW & ASSOCIATES




YOSHINO-SHAW & ASSOCIATES
= Jim Shaw, esq.
ARCHITECT

105 N. GOLDEN STATE BLVD
TURLOCK, CA 95360
Phone: (209) 667-2603
Fax: (209) 667-2604
Email: jshaw@y-s-a.com

SHEET NO.
A-3.0

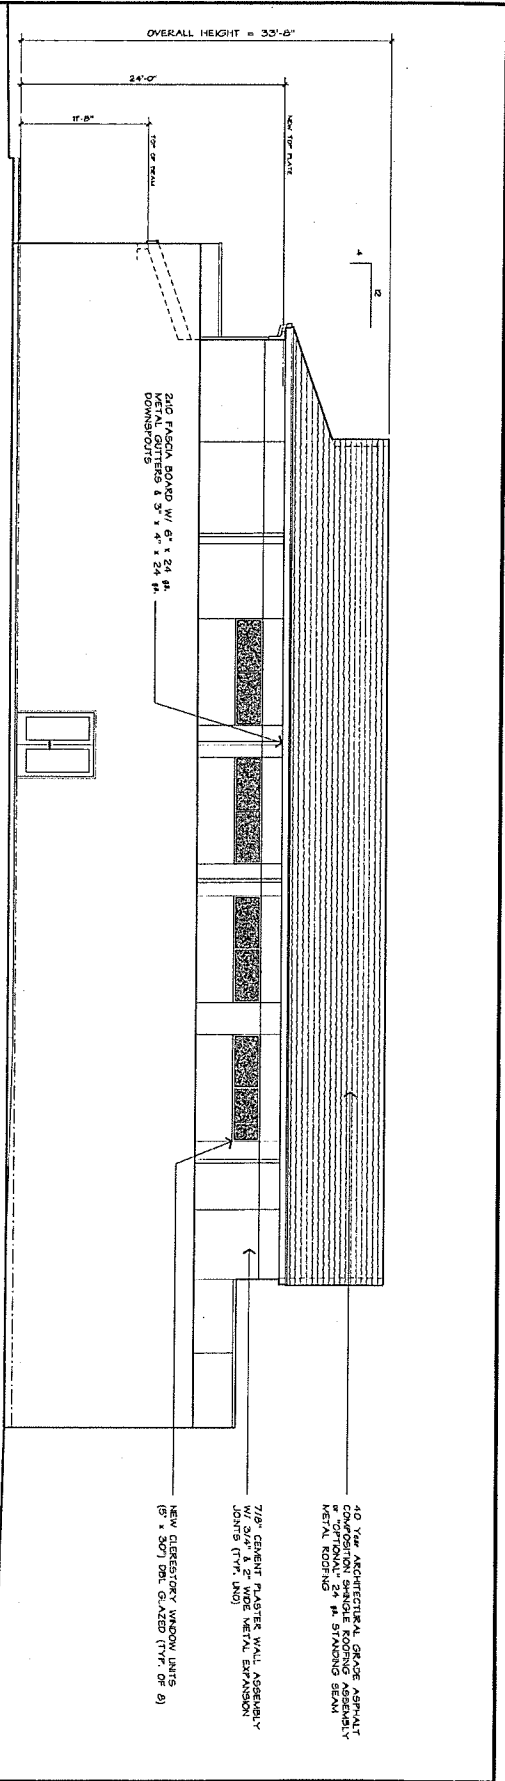

SOUTH (Side) ELEVATION

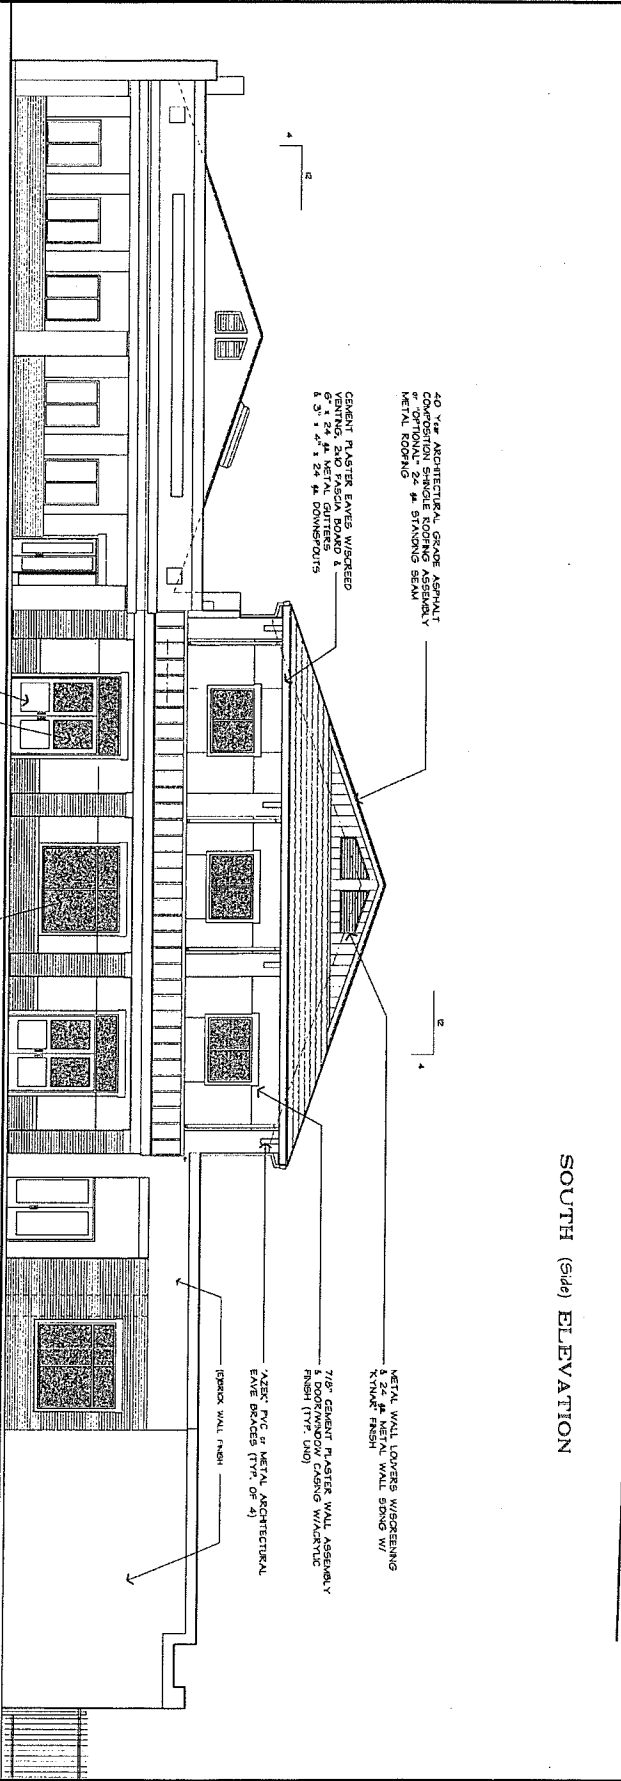

WEST (Front) ELEVATION

PROPOSED EXTERIOR ELEVATIONS
SCALE: 3/8" = 1'-0"

A


YOSHINO-SHAW & ASSOCIATES
ARCHITECT
JIM SHAW
205 N. GARDEN STATE BLVD
TURLOCK, CA 95250
Phone: (209) 667-2025
Fax: (209) 667-2027
Email: jshaw@yoshino.com

PROJECT NAME: SANCTUARY & FACADE UPGRADES FOR :
CALVARY CHAPEL CHURCH
147 S. BROADWAY AVE
TURLOCK, CA


SHEET TITLE: PROPOSED ELEVATIONS
DATE: 1/24/19
DRAWN BY: JDS
JOB NUMBER: 1014
SIGNATURE: © 2019 YOSHINO-SHAW & ASSOCIATES

REVISIONS

REGISTERED ARCHITECT
JAMES D. SHAW
C-07280
STATE OF CALIFORNIA

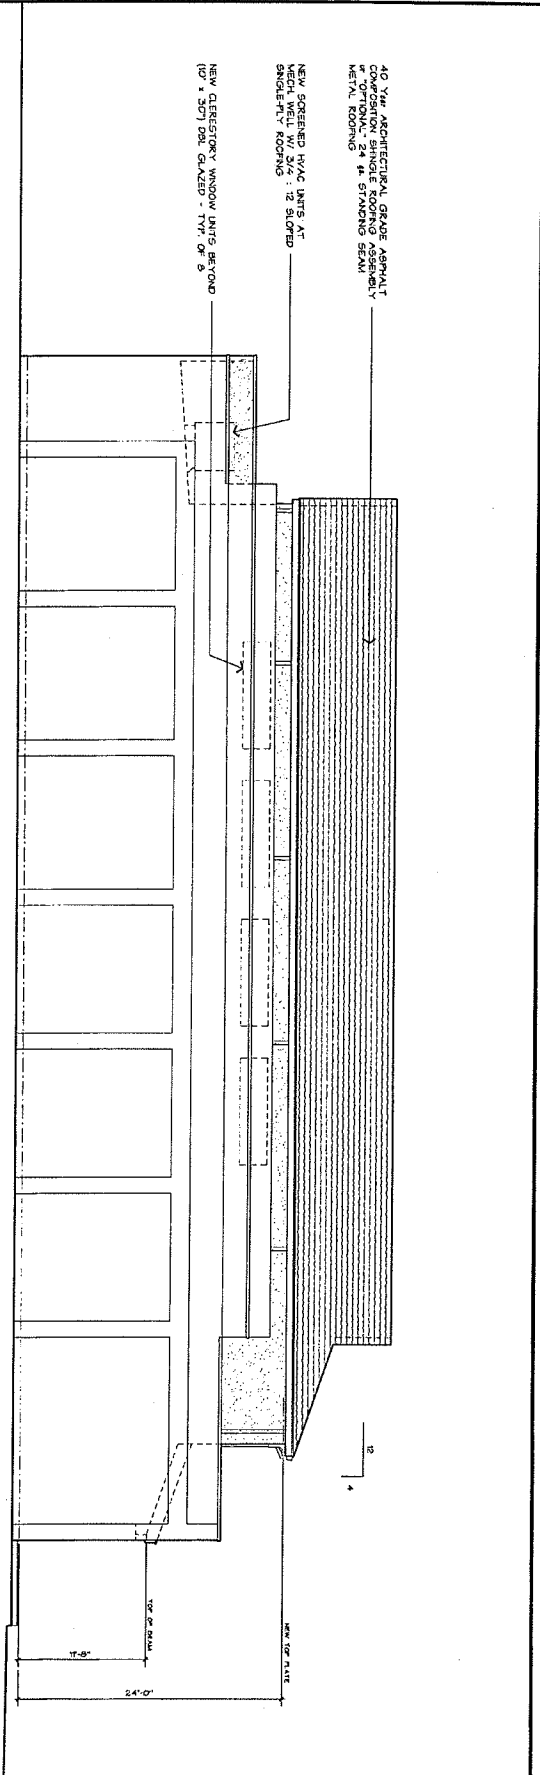

NORTH (Side) ELEVATION

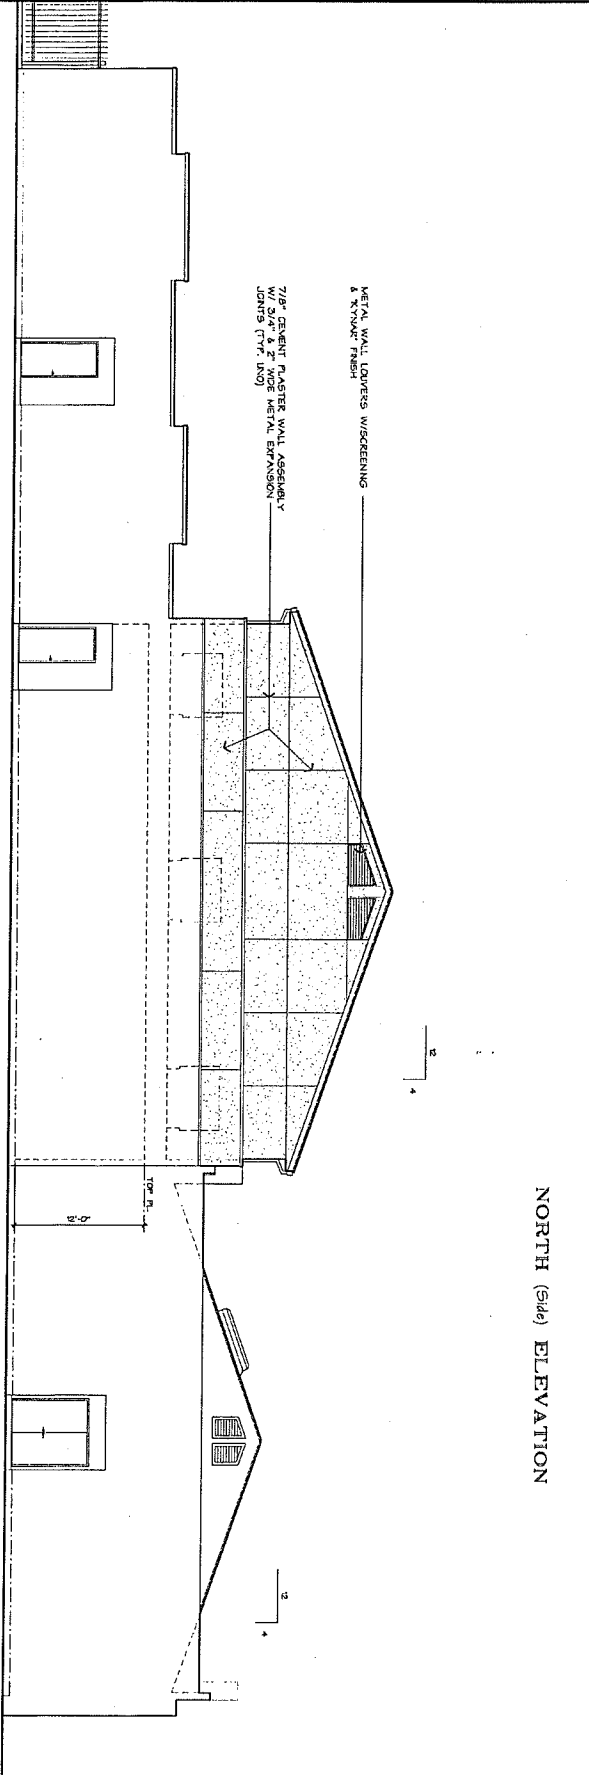

EAST (Rear) ELEVATION

PROPOSED EXTERIOR ELEVATIONS

SCALE: 3/8" = 1'-0"

A

REVISIONS



PROJECT NAME: SANCTUARY & FACADE UPGRADES FOR :

CALVARY CHAPEL CHURCH

147 S. BROADWAY AVE
TURLOCK, CA

SHEET TITLE: PROPOSED ELEVATIONS CONT.	DATE 1/24/19	DRAWN BY: JDS	JOB NUMBER: 1014	SIGNATURE
---	-----------------	------------------	---------------------	-----------

© 2019 YOSHINO-SHAW & ASSOCIATES




YOSHINO-SHAW & ASSOCIATES
ARCHITECT


Jim Shaw
108 N. GARDEN STREET, SUITE 200
TURLOCK, CA 95380

Phone: (209) 887-2600
Fax: (209) 887-2604
Email: jshaw@yoshino.com

SHEET NO.
A-3.3

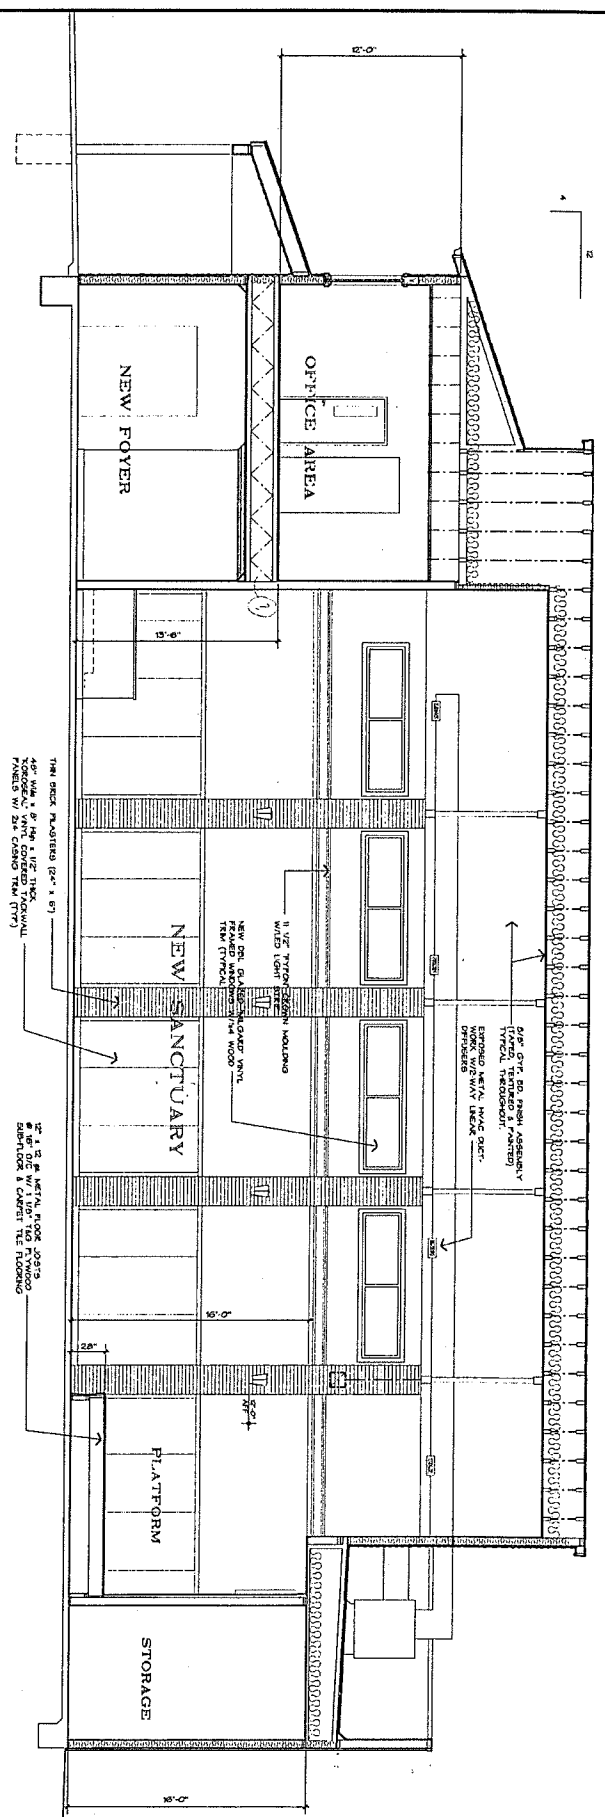

NEW CROSS SECTION
SCALE: 1/4" = 1'-0"

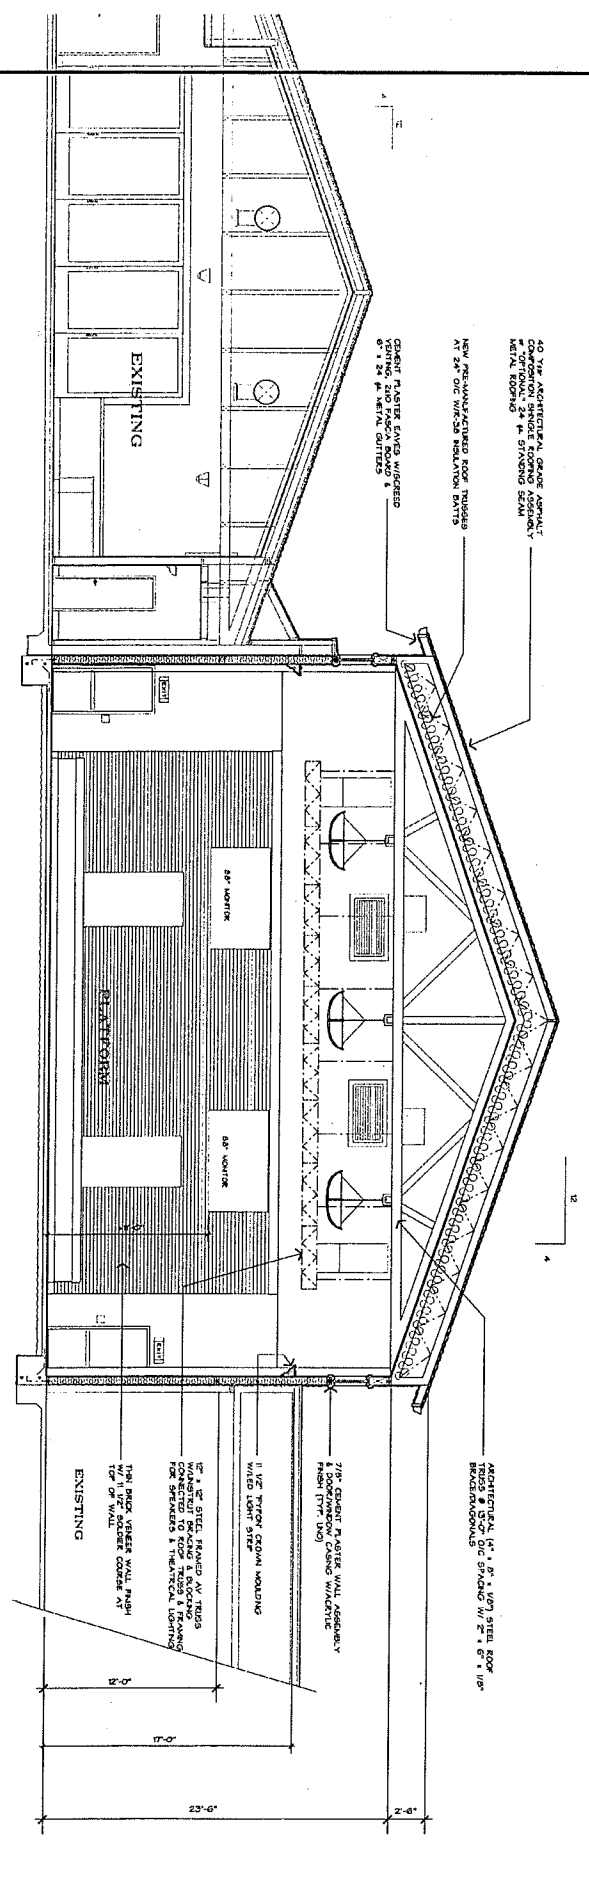

NEW CROSS SECTION
SCALE: 1/4" = 1'-0"

REVISIONS



PROJECT NAME: SANCTUARY & FACADE UPGRADES FOR :

CALVARY CHAPEL CHURCH
147 S. BROADWAY AVE
TURLOCK, CA

SHEET TITLE: NEW CROSS SECTIONS

DATE: 1/24/19

DRAWN BY: JDS

JOB NUMBER: 1614

SIGNATURE: _____

© 2019 YOSHINO-SHAW & ASSOCIATES



YOSHINO-SHAW & ASSOCIATE ARCHITECTS
JIM SHAW
ARCHITECT

ONE N. GARDEN STATE BLVD
TURLOCK, CA 95300

Phone: (209) 667-2603
Fax: (209) 667-2604
Email: jshaw@yoshino-shaw.com


SHEET NO. **A-4.0**

ARCHITECTURAL STEEL ROOF TRUSS
ROOFES 8'-0" O.C. SPACING

7/8" GRADE FINDER WALL FINISH
ASSEMBLY & WINDOW CASES W/
ASTLE FINISH (1/2" S&G)

EXISTING BLDG

REMOVE EXISTING CONCRETE FOOTINGS
FOR STRUCTURAL CLAMP
5' 1/2" HIGH WOOD PALE BOARD
(TYPICAL USE)

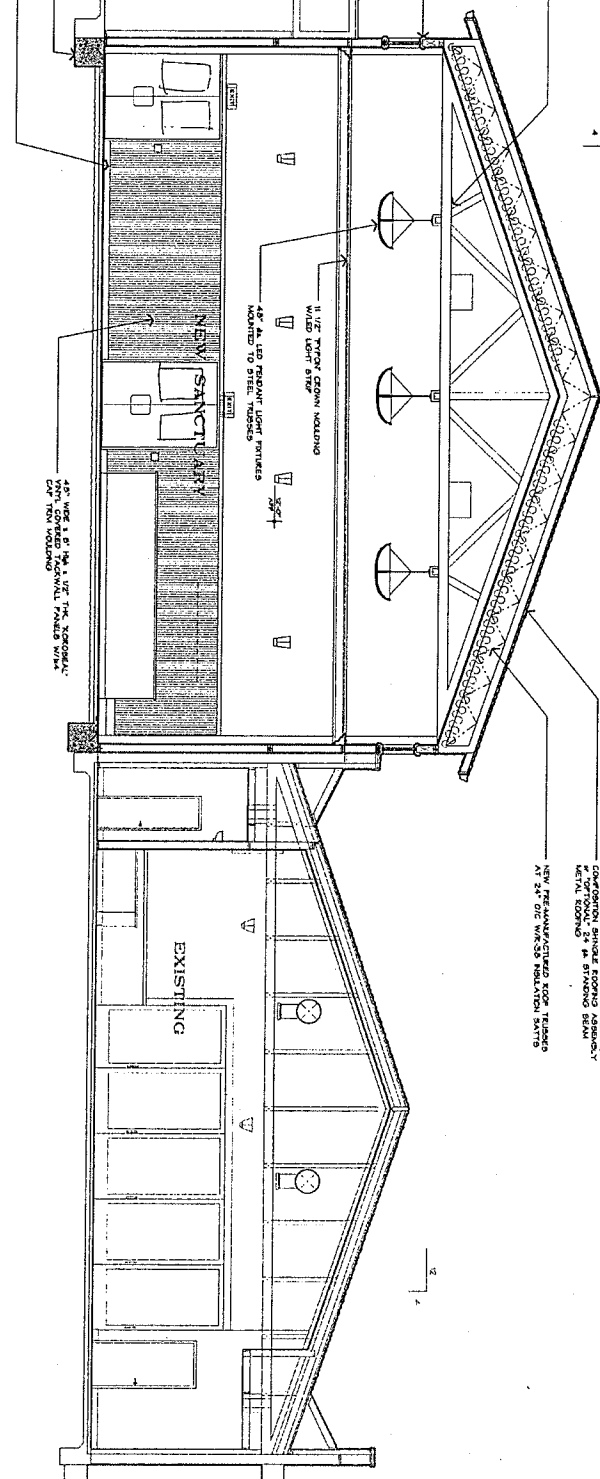

1 1/2" TYPICAL SPACING HOLDING
W/LED LIGHT FIXTURE

48" AL LED FRONT LIGHT FIXTURES
MOUNTED TO STEEL TRUSSES

NEW SANCTUARY

48" WIDE 1 1/2" HIGH 1 1/2" TYPICAL
SPACING COVERED W/ALUMINUM PANELS W/AL
CLIP NON HOLDING

20' HIGH ARCHITECTURAL STEEL ROOF TRUSS
CONCRETE 24" X 24" SPACING BEAM
WITH INSULATION

NEW MANUFACTURED ROOF TRUSS
AT 24" O.C. WITH INSULATION BATT

NEW CROSS SECTION

SCALE: 1/4" = 1'-0"

A

C

PROJECT NAME: SANCTUARY & FACADE UPGRADES FOR :

CALVARY CHAPEL CHURCH
147 S. BROADWAY AVE
TURLOCK, CA

SHEET TITLE: CROSS SECTION CONT.

DATE: 1/24/19

DRAWN BY: JDS

JOB NUMBER: 1814

SIGNATURE: © 2019 YOSHINO-SHAW & ASSOCIATES

REVISIONS

YOSHINO-SHAW & ASSOCIATES
ARCHITECT

— Jim Shaw —
ARCHITECT

106 N. GOLDEN STATE BLVD
TURLOCK, CA 95260

Phone: (209) 687-2603
Fax: (209) 687-2804
Email: jshaw@yoshino-shaw.com

SHEET NO. **A-4.1**

